


LIGHTING LAYOUT NOTES

- THIS DRAWING SHALL BE READ IN CONJUNCTION WITH THE ELECTRICAL SERVICES SECTION OF THE SPECIFICATION, THE ARCHITECTURAL DRAWINGS AND ALL OTHER RELEVANT SERVICES DRAWINGS.
- REFER TO THE LEGEND AND LIGHT FITTING SCHEDULE.
- SUPPLY AND INSTALL AN UNSWITCHED ACTIVE CABLE FROM THE DISTRIBUTION BOARD TO EACH EMERGENCY LUMINAIRE AND EXIT SIGN FOR TESTING PURPOSES AS REQUIRED BY AS2293.
- ALL EQUIPMENT AND ACCESSORIES SHALL BE NEW UNLESS NOTED OTHERWISE.
- FINAL POSITION OF ALL EQUIPMENT TO BE DETERMINED ON SITE PRIOR TO INSTALLATION. REFER TO ARCHITECTURAL FITOUT DRAWINGS.
- RATINGS AND TERMINATIONS OF ALL EQUIPMENT TO BE CONFIRMED WITH SUPPLIER/MANUFACTURER'S RECOMMENDATIONS PRIOR TO INSTALLATION.

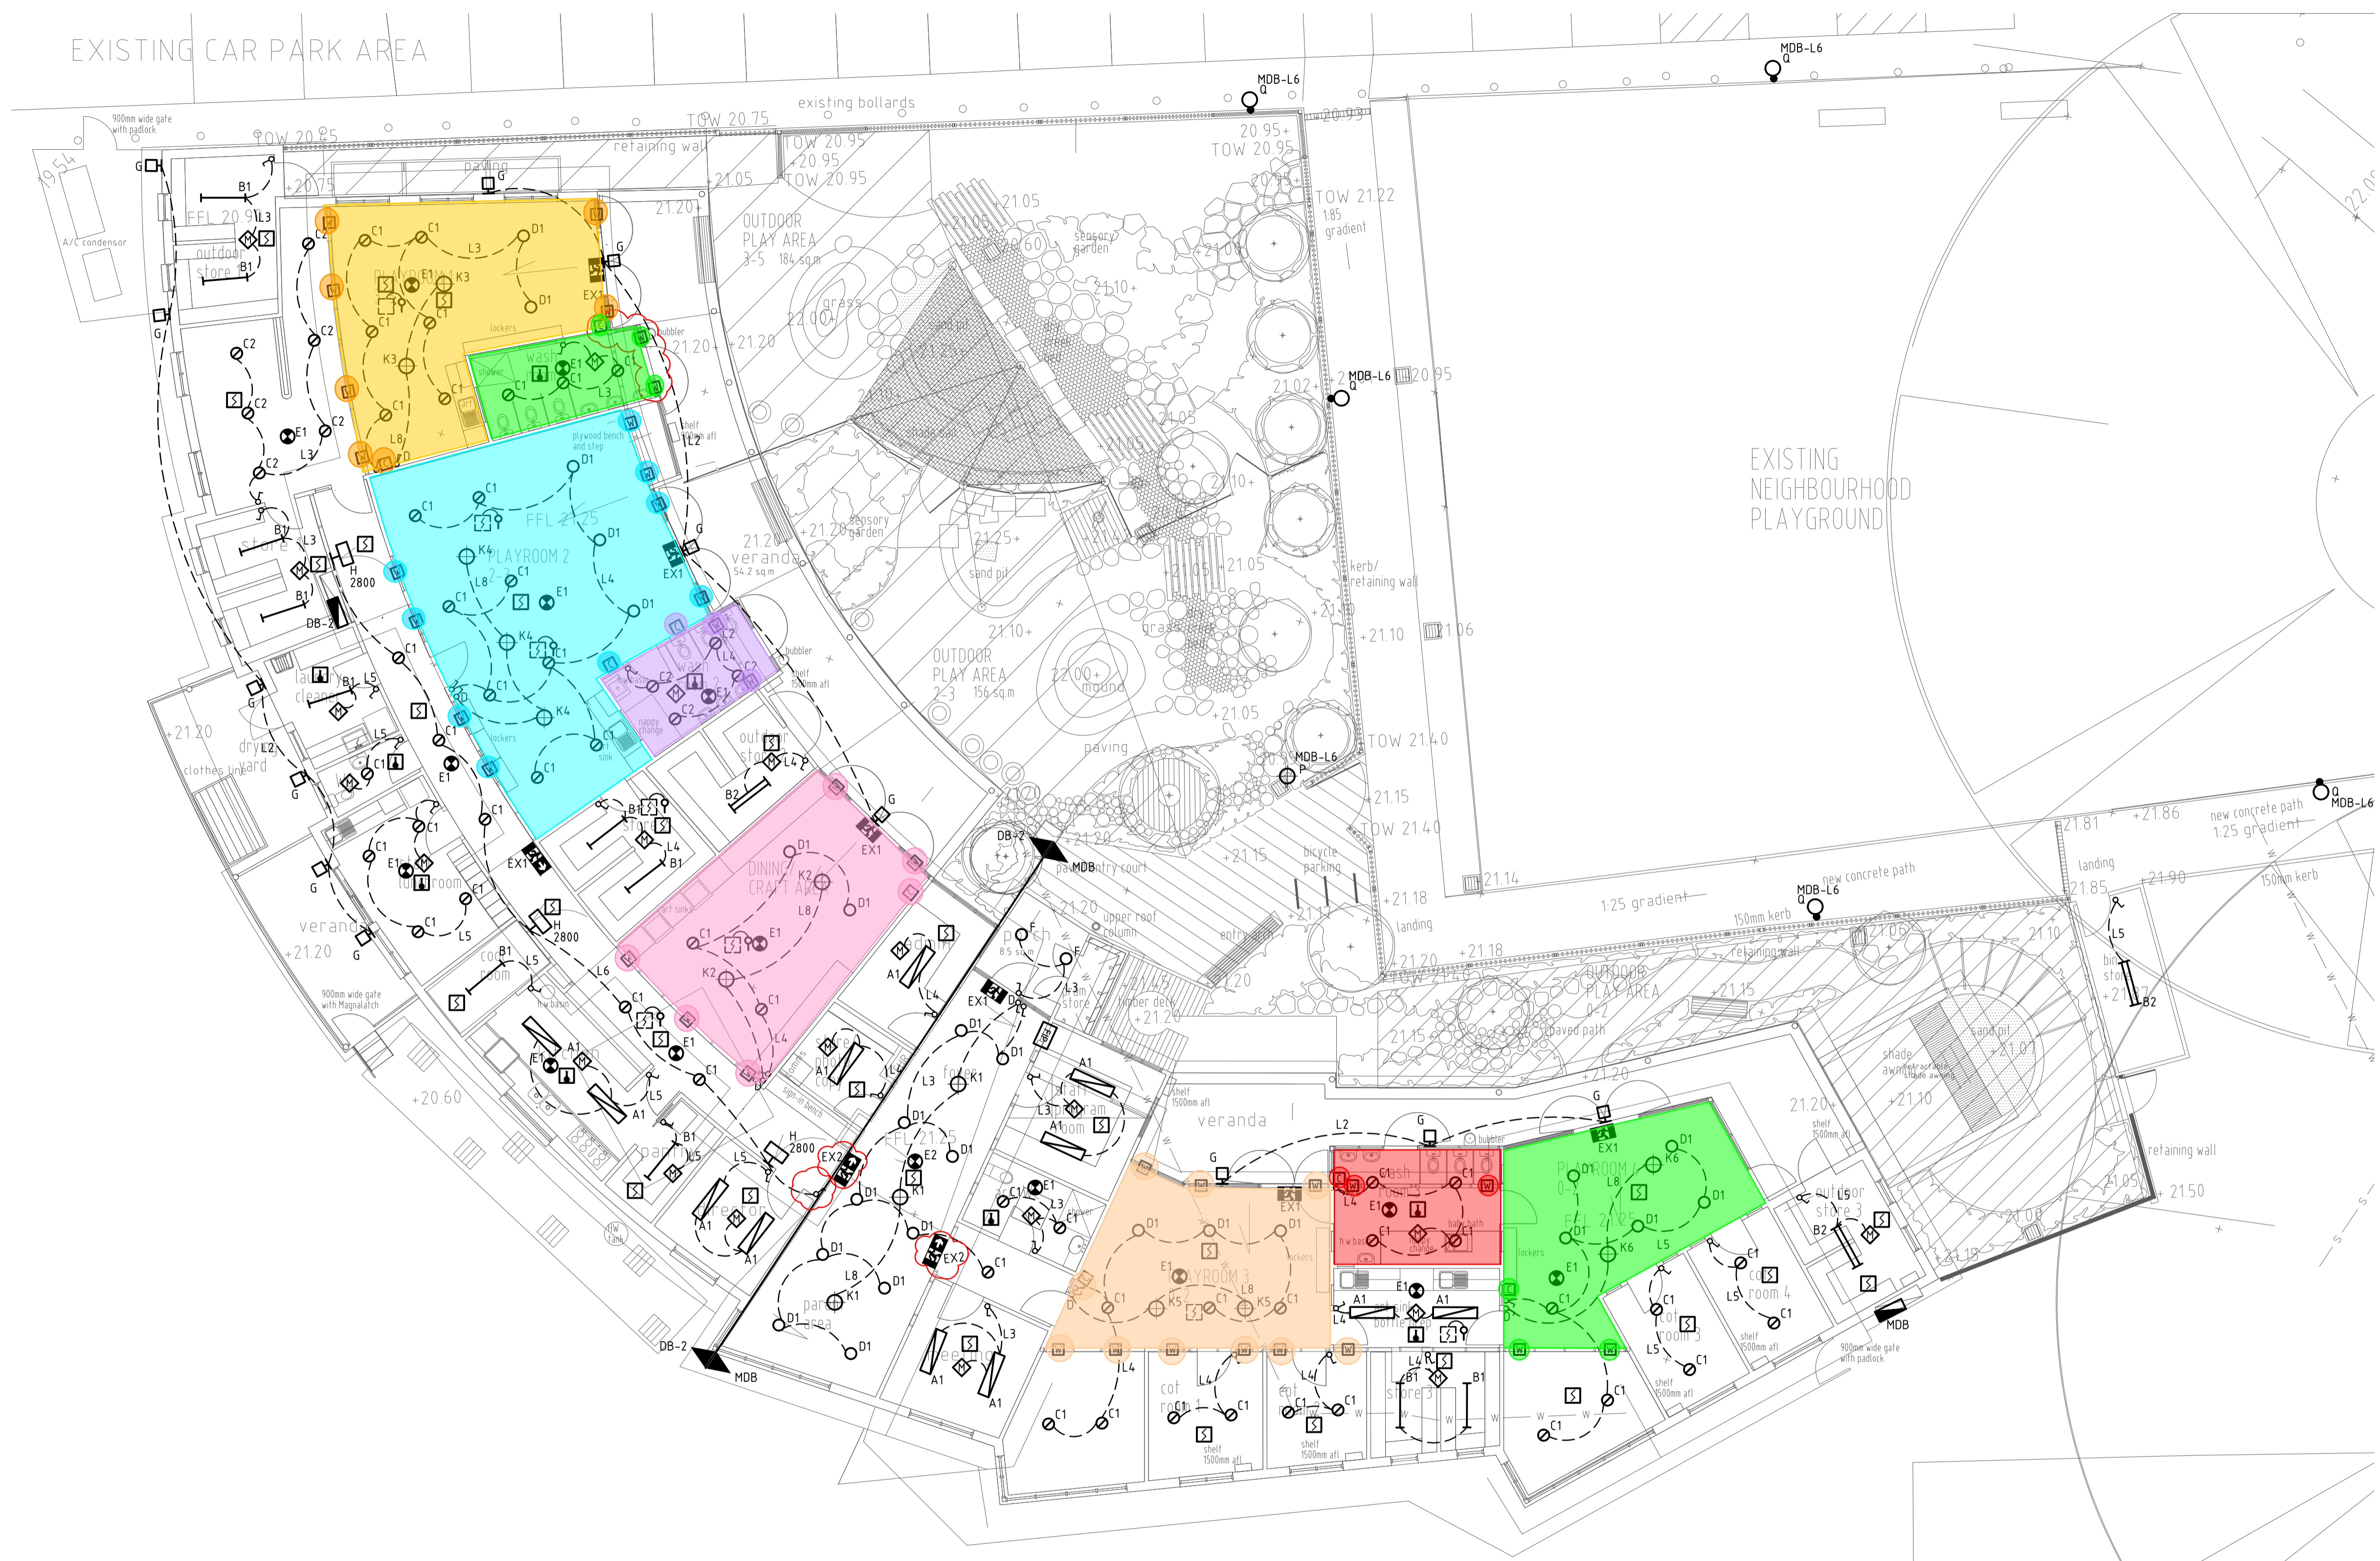

3	CONSTRUCTION ISSUE	JRR	PGM	27.10.16
2	CONSTRUCTION ISSUE	JRR	PGM	08.09.16
1	CONSTRUCTION ISSUE	JRR	PGM	07.07.16
0	CONSTRUCTION ISSUE	JRR	PGM	17.07.15
F	TENDER ISSUE	JRR	PGM	15.04.15
E	TENDER ISSUE	JRR	PGM	23.03.15
REV.	DESCRIPTION	DRAWN	APP'D	DATE

CLIENT :
 Leichhardt Municipal Council
 7-15 Wetherill Street
 LEICHHARDT NSW 2040

ARCHITECT :
Dillon & Savage Architects
 40 Quinton Rd, Manly, 2095
 Phone: (02) 9977 3714 Fax: (02) 9977 8215
 email: dsarch@bigpond.net.au

WOOD & GRIEV ENGINEERS
 Wood & Griev Engineers Ltd
 A.C.N. 137 999 809
 Level 6, Building B,
 207 Pacific Highway, St Leonards
 New South Wales 2065
 Phone: 02 8484 7100
 Fax: 02 8484 7100
 Email: sydney@wge.com.au
 Web: www.wge.com.au

PROJECT:
LEICHHARDT PARK CHILD CARE

TITLE:
 ELECTRICAL SERVICES
 LIGHTING AND FIRE DETECTION
 LAYOUT

FOR CONSTRUCTION

DESIGNED : PGM	VERIFIED :	PGM
DRAWN : MPH	APPROVED FOR TENDER :	PGM
SCALE : 1:100	APPROVED FOR CONSTRUCTION :	PGM

CAD FILE: E-100-LIGHTING.dwg PLOT DATE/TIME: 27.10.16 11:37 AM

PROJECT No. 26687-SYD	DRAWING No. E-100	REVISION 3
---------------------------------	-----------------------------	----------------------



SCHEDULE OF CIRCUITS

MDB
 18 POLE CHASSIS

CIRCUIT NUMBER	L1	L2	L3	L4	L5	L6	L7	L8	L9	L10	L11	L12	L13	L14	L15	L16	L17	L18
PROTECTION	16 A	16 A	16 A	16 A	16 A	16 A	16 A	16 A	16 A	30 mA	30 mA	30 mA	30 mA	30 mA	30 mA	30 mA	30 mA	30 mA
CONTROL	EM	EX	LS	LS	LS	EX	WS	WD	-	-	-	-	-	-	-	-	-	-

SCHEDULE OF CIRCUITS

DB-2
 18 POLE CHASSIS

CIRCUIT NUMBER	L1	L2	L3	L4	L5	L6	L7	L8	L9	L10	L11	L12	L13	L14	L15	L16	L17	L18
PROTECTION	16 A	16 A	16 A	16 A	16 A	16 A	16 A	16 A	16 A	30 mA	30 mA	30 mA	30 mA	30 mA	30 mA	30 mA	30 mA	30 mA
CONTROL	EM	EX	LS	LS	LS	LS	WS	WD	-	-	-	-	-	-	-	-	-	-