


**LOWER GROUND FLOOR - LIGHTING LAYOUT**  
SCALE 1:100

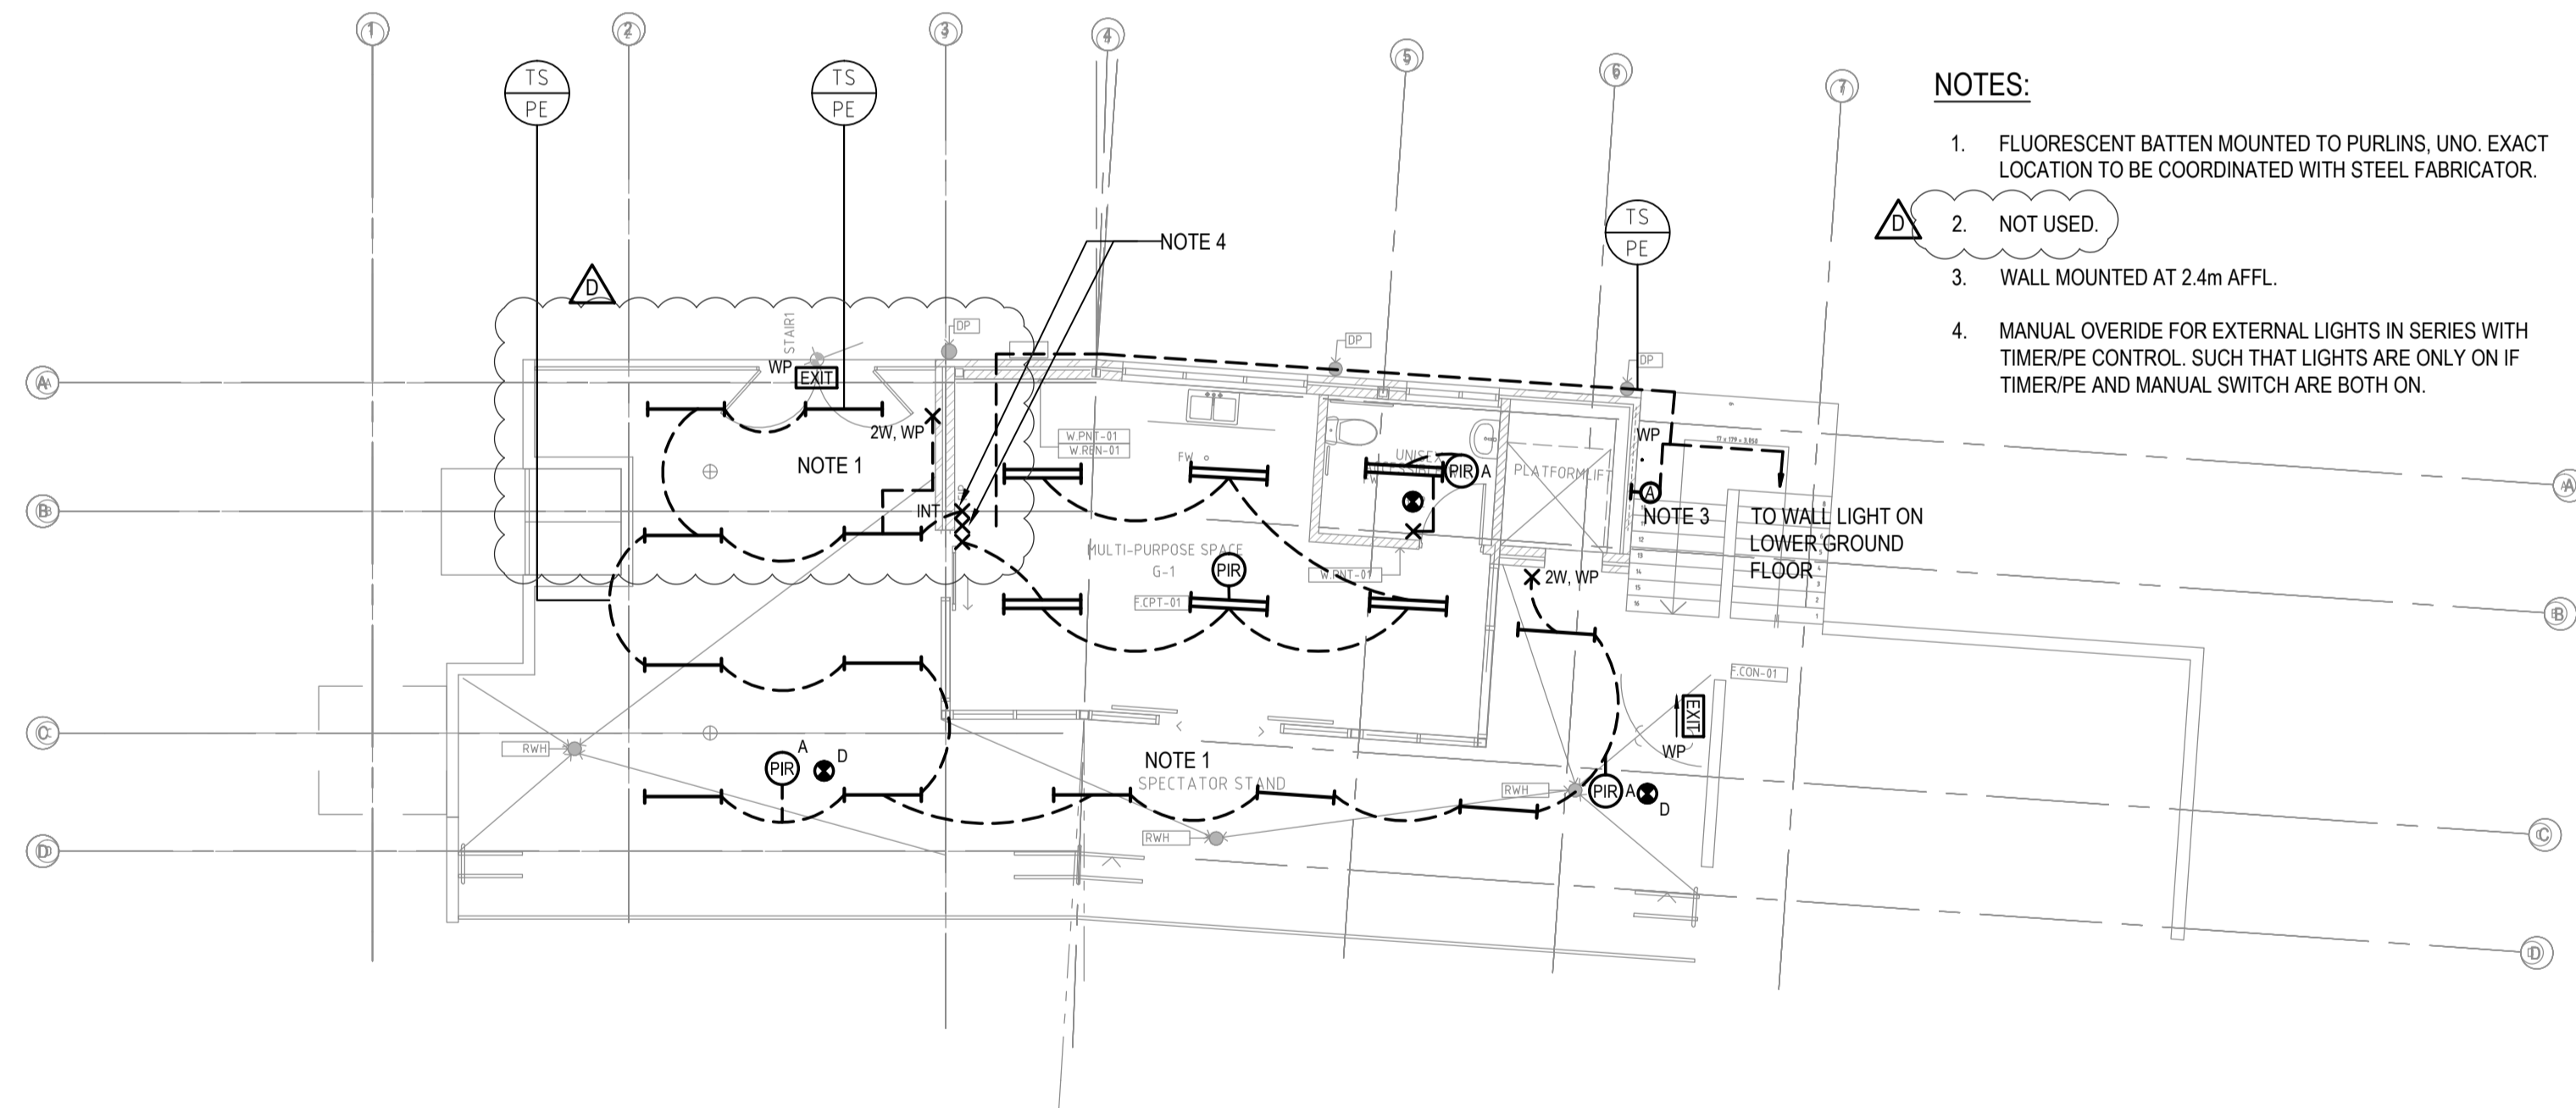

**NOTES:**

1. FLUORESCENT BATTEN MOUNTED TO PURLINS, UNO. EXACT LOCATION TO BE COORDINATED WITH STEEL FABRICATOR.
2. NOT USED.
3. WALL MOUNTED AT 2.4m AFFL.
4. MANUAL OVERRIDE FOR EXTERNAL LIGHTS IN SERIES WITH TIMER/PE CONTROL. SUCH THAT LIGHTS ARE ONLY ON IF TIMER/PE AND MANUAL SWITCH ARE BOTH ON.

**GROUND FLOOR - LIGHTING LAYOUT**  
SCALE 1:100

Rev.	Date	Description	Des.	Verif.	Appd.
D	08.09.2016	CONSTRUCTION ISSUE	C.H.	V.S.	B.P.
C	11.04.2016	CONSTRUCTION CERTIFICATE ISSUE	C.H.	V.S.	B.P.
B	18.03.2016	CONSTRUCTION CERTIFICATE ISSUE	C.H.	V.S.	B.P.
02	11.03.2016	PRELIMINARY ISSUE FOR COMMENT	C.H.	V.S.	B.P.
A	27.10.2015	TENDER ISSUE	C.H.	V.S.	B.P.
01	08.09.2015	PRELIMINARY ISSUE	C.H.		

© Cardno Limited All Rights Reserved.  
This document is produced by Cardno Limited solely for the benefit of and use by the client in accordance with the terms of the retainer. Cardno Limited does not and shall not assume any responsibility or liability whatsoever to any third party arising out of any use or reliance by third party on the content of this document.

Cardno (NSW/ACT) Pty Ltd | ABN 95 001 145 035  
Level 9, The Forum, 203 Pacific Highway  
St Leonards, NSW 2065  
Tel: 02 9496 7700 Fax: 02 9439 5170  
Web: www.cardno.com.au

Drawn	C.O.	Date	Sept '16
Checked	M.D.	Date	Sept '16
Designed	C.O.	Date	Sept '16
Verified	L.K.K.	Date	Sept '16
Approved	B.P.	Date	Sept '16

Client	BRIARS SPORTING CLUB
Project	COMMUNITY AND AMENITIES BUILDING ROTHWELL PARK, CONCORD
Title	ELECTRICAL SERVICES LOWER GROUND FLOOR & GROUND FLOOR LIGHTING LAYOUT

Status	<b>FOR CONSTRUCTION</b>		
Scale	1:100	Size	A1
Drawing Number	80816048-EL-1002	Revision	D