
 


**NOTES:**  
 1. ALLOW FOR ACOUSTIC WRAPPING TO ALL FANS, REFER GENERAL NOTES ON ME-0001 FOR ACOUSTIC NOISE PERFORMANCE LEVELS.

**LOWER GROUND FLOOR - A/C & VENTILATION LAYOUT**  
 SCALE 1:100

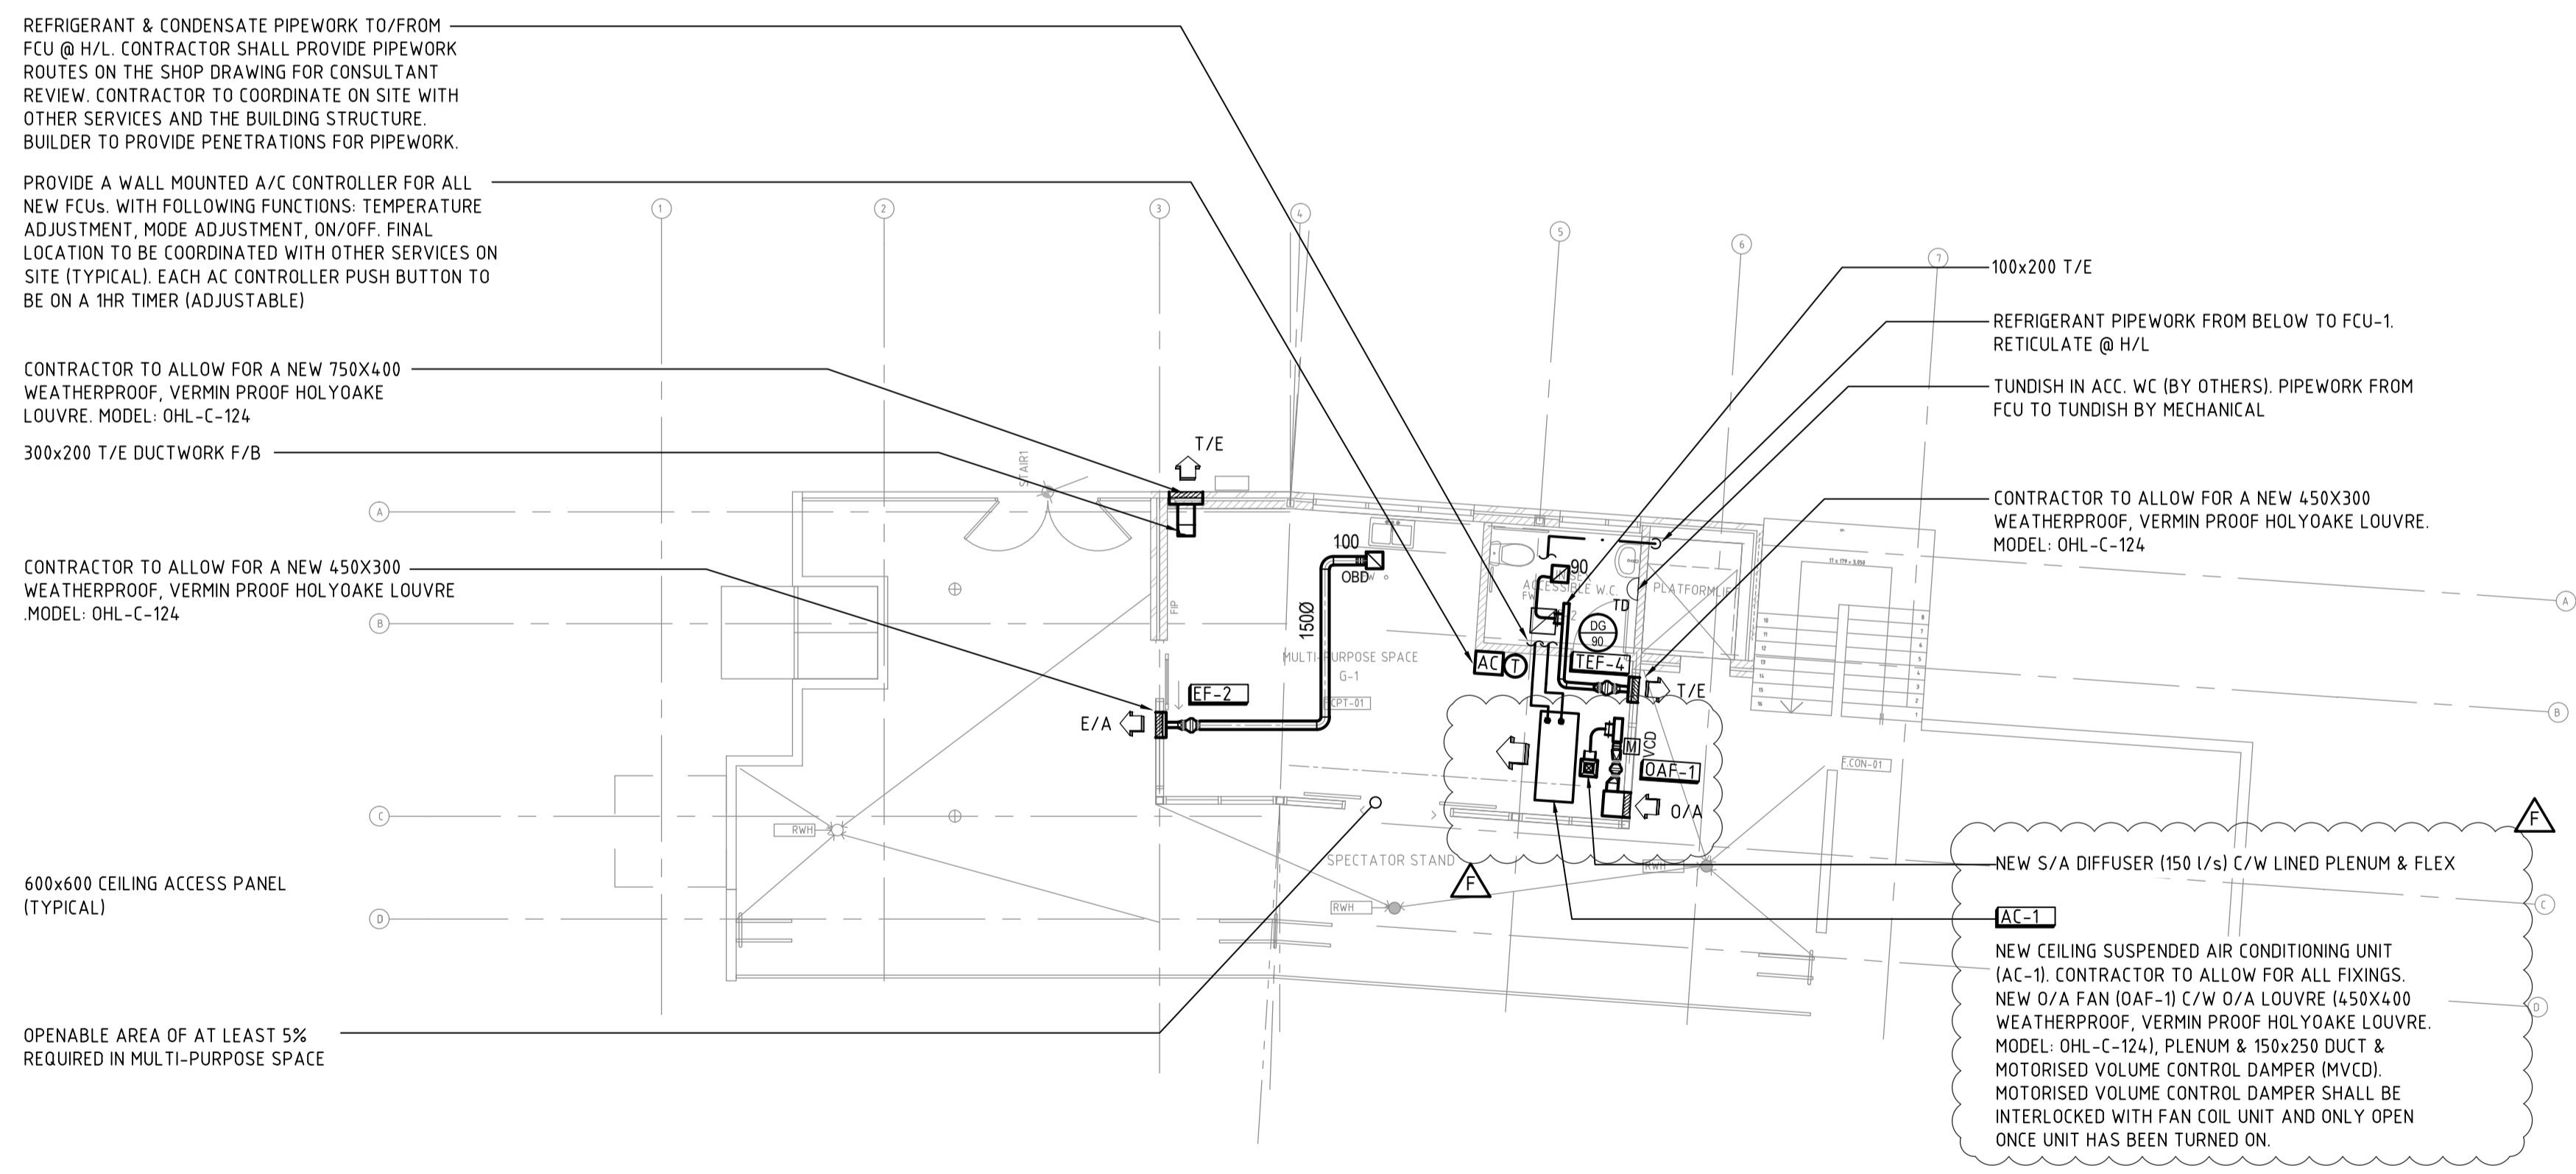

**GROUND FLOOR - A/C & VENTILATION LAYOUT**  
 SCALE 1:100



XREFS: X:TBLOCK-A1 (Cardno); H:XA-TOILET-PLAN-EX; XA-GF-PLAN; XA-GRID; XA-LGF-PLAN; 80816048-EL-1002  
 CAD File: N:\Projects\80816048 - Community Facility Rothwell Park\Drawings\Build\80816048-ME-1001.dwg

| Rev. | Date       | Description                    | Des. | Verif. | Appd. | Rev. | Date | Description | Des. | Verif. | Appd. |
|------|------------|--------------------------------|------|--------|-------|------|------|-------------|------|--------|-------|
| F    | 01.02.2017 | REVISED AS CLOUDED             | R.T. | R.W.   | R.T.  |      |      |             |      |        |       |
| E    | 16.01.2017 | A/C ADDED                      | R.T. | R.W.   | R.T.  |      |      |             |      |        |       |
| D    | 08.09.2016 | CONSTRUCTION ISSUE             | M.Z. | R.T.   | B.P.  |      |      |             |      |        |       |
| C    | 11.04.2016 | CONSTRUCTION CERTIFICATE ISSUE | R.T. | B.P.   | B.P.  |      |      |             |      |        |       |
| B    | 18.03.2016 | CONSTRUCTION CERTIFICATE ISSUE | R.T. | B.P.   | B.P.  |      |      |             |      |        |       |
| O2   | 11.03.2016 | PRELIMINARY ISSUE FOR COMMENT  | R.T. | B.P.   | B.P.  |      |      |             |      |        |       |
| A    | 27.10.2015 | TENDER ISSUE                   | R.T. | B.P.   | B.P.  |      |      |             |      |        |       |
| O1   | 08.09.2015 | PRELIMINARY ISSUE              | R.T. |        |       |      |      |             |      |        |       |

© Cardno Limited All Rights Reserved.  
 This document is produced by Cardno Limited solely for the benefit of and use by the client in accordance with the terms of the retainer. Cardno Limited does not and shall not assume any responsibility or liability whatsoever to any third party arising out of any use or reliance by third party on the content of this document.

Cardno (NSW/ACT) Pty Ltd | ABN 95 001 145 035  
 Level 9, The Forum, 203 Pacific Highway  
 St Leonards, NSW 2065  
 Tel: 02 9496 7700 Fax: 02 9439 5170  
 Web: www.cardno.com.au

|                  |                  |   |
|------------------|------------------|---|
| Drawn<br>M.Z.    | Date<br>Sept '16 | Client<br><b>BRIARS SPORTING CLUB</b>   |
| Checked<br>M.D.  | Date<br>Sept '16 | Project<br><b>COMMUNITY AND AMENITIES BUILDING<br/>ROTHWELL PARK, CONCORD</b>                             |
| Designed<br>R.T. | Date<br>Sept '16 | Status<br><b>FOR CONSTRUCTION</b>   |
| Verified<br>R.T. | Date<br>Sept '16 | Title<br><b>MECHANICAL SERVICES<br/>LOWER GROUND FLOOR &amp; GROUND FLOOR<br/>AIR CONDITIONING LAYOUT</b> |
| Approved<br>B.P. | Date<br>Sept '16 | Drawing Number<br><b>80816048-ME-1001</b>   |
|                  |                  | Scale<br>1:100  |
|                  |                  | Size<br>A1  |
|                  |                  | Revision<br><b>F</b>  |